



REPÚBLICA DEMOCRÁTICA DE TIMOR LESTE



MINISTRY OF HEALTH

REHABILITATION OF MATERNITY IN RIAMARI, BAUCAU, TIMOR LESTE

ISSUE : CONSTRUCTION ISSUE
2025

ARSITECTURAL DRAWING

Maternidade Riamare

Write a description for your map.

Legend

- Maternidade 6°27'30.86"S 126°26'56.06"E
- Feature 1
- Hospital Bauoli Ria Mhare
- KIOS KAMANA
- Untitled Polygon



Google Earth



Imagem © 2025 CNES / Airbus

PROJECT OWNER

Desing by :



Direcao Nacional
Logistic i patrimonio

MINIST

PROJECT DETAILS

Project:
REHABILITATION OF MATERNITY BUILDING

Site: BAUCAU RIAMARI
TIMOR-LESTE

Building Title:
MATERNITY BUILDING

Drawing Title:

Scale

Drawing By

Lucas Gomes B. Bato
Engenheiro Arquiteto

Date: 2025

Checked By

Isaias Lino Borges
Engenheiro Arquiteto

Date: 2025

Reviso By

Belchior Soares
Chefe DAPY MS

Date: 2025

Knowledge By

Indosol
Diretor NALP

Date: 2025

Drawing No.

Issue: 2025

NOTES

USE PROVIDED DIMENSIONS IN PREFERENCE TO SCALE
ALL DIMENSIONS TO BE VERIFIED AND CHECKED ON SITE
ALL DIMENSIONS IN MILLIMETER

No. ISSUE / AMENDMENT DATE INITIAL


1			
2			
3			
4			
5			
6			



INCT

LEGEND :

- ① IN A EXH
- ② MATERNITY BUILDING
- ③ NEW CONSTRUCTION LAUNDRY
- ④ NEW CONSTRUCTION WATER TOWER
- ⑤ RESIDENT COMMUNITY
- ⑥ AMPLANCE PARKING
- ⑦ EXISTING BUILDING
- ⑧ 1P BUILDING
- ⑨ EXISTING BUILDING
- ⑩ EXISTING BUILDING
- ⑪ EXISTING SCHOOL
- ⑫ SETTLEMENT
- ⑬ ACCESS ROAD

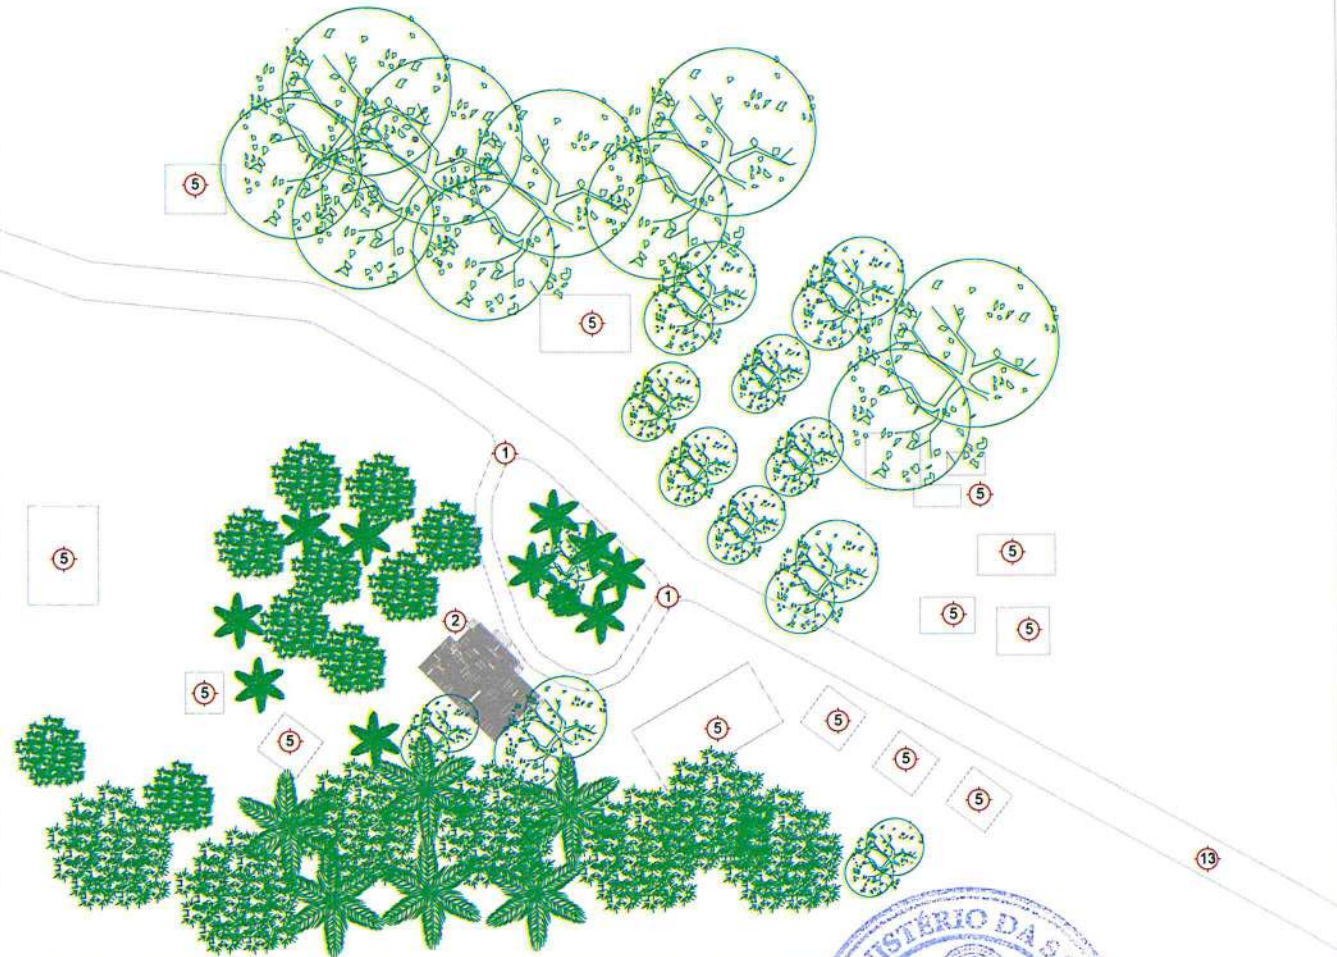

PROJECT OWNER

Desing by :

Direcao Nacional
Logistic i patrimonio

PROJECT DETAILS

Project:
REHABILITATION OF MATERNITY BUILDING

Site:
BAUCAU RIAMARI
TIMOR-LESTE

Building Title:
MATERNITY BUILDING

Drawing Title:

Scale

Drawing By

Lucas Gomes Babo
Engineering Unit

Date
/ / 2025

Checked By

Isaías Lino Borges
Engineering Unit

Date
/ / 2025

Revis By

Berthor Soares
Chief DAFF MS

Date
/ / 2025

Knowledge By

Indesaf
Director NALP

Date
/ / 2025

Drawing No

Issue
/ 2025

Issue
/ 2025

NOTES

UNITS: ALL DIMENSIONS IN PREFERENCE TO SCALE
ALL DIMENSIONS TO BE VERIFIED AND CHECKED ON SITE
ALL DIMENSIONS IN MILLIMETER

NO.	ISSUE / AMENDMENT	DATE	INITIAL
1			
2			
3			
4			
5			
6			



MINIST



LEGEND :

- ① EXISTING
- ② EXISTING MATERNITY BUILDING
- ③ EXISTING MATERNITY BUILDING
- ④ EXISTING MATERNITY BUILDING
- ⑤ EXISTING MATERNITY BUILDING
- ⑥ EXISTING MATERNITY BUILDING
- ⑦ EXISTING MATERNITY BUILDING
- ⑧ EXISTING MATERNITY BUILDING
- ⑨ EXISTING MATERNITY BUILDING
- ⑩ EXISTING MATERNITY BUILDING
- ⑪ EXISTING MATERNITY BUILDING
- ⑫ EXISTING MATERNITY BUILDING
- ⑬ EXISTING MATERNITY BUILDING



Site
Coordinate
9° 9' 57.526"
S
125° 16'
1.081"E

SITE EXISTING
SCALE 1:100



PROJECT OWNER



Direcção Nacional
Logística e património

MINISTÉRIO DA SAÚDE

Desing by :

Project:
REHABILITATION OF MATERNITY BUILDING

Site: BAUCAU RIAMARI
TIMOR-LESTE

Building Title:
MATERNITY BUILDING

Drawing Title:

Scale

PROJECT DETAILS

Drawing By

Checked By

Reviso By

Knowledge By

Drawing No.

Lucas Gomes Bbabo
Engineering-Mch

Isaías Lino borges
Engineering-Mch

Belchior Soares
Chefe DAP/IMS

Director BAP

Date
...../2025

Date
...../2025


Date
...../2025

Date
...../2025

Issue
2025

USE FIGURED DIMENSIONS IN PREFERENCE TO SCALE
ALL DIMENSIONS TO BE VERIFIED AND CHECKED ON SITE
ALL DIMENSIONS IN MILLIMETER

No.	ISSUE / AMENDMENT	DATE	INITIAL
1			
2			
3			
4			
5			
6			

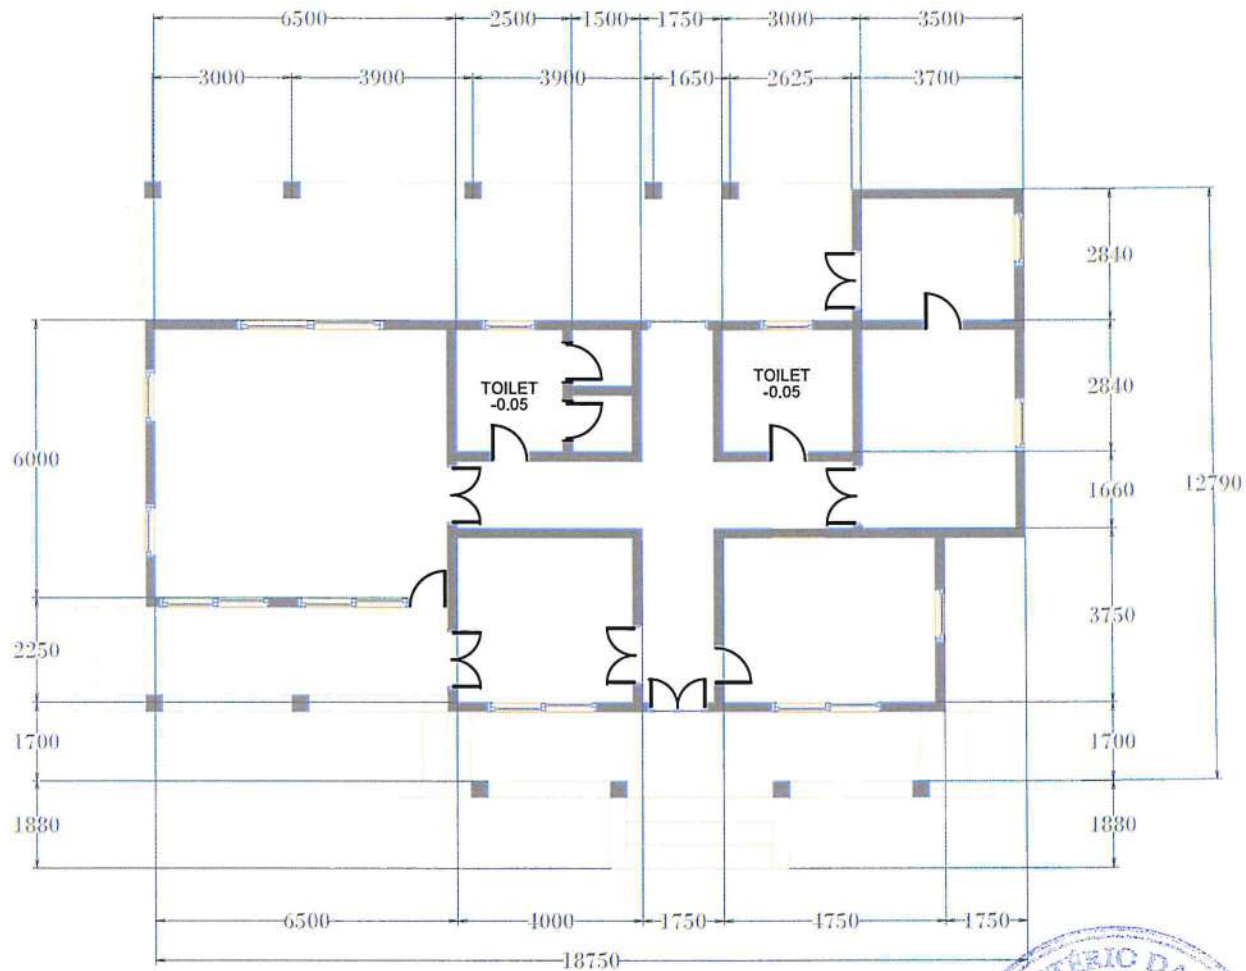

FLOOR PLAN

SCALE 1:100



REP. OF TIMOR-LESTE



MINISTÉRIO DA SAÚDE

Direção Nacional
Logística e património

Desing by :

Project:
REHABILITATION OF MATERNITY BUILDING

Site:
BAUCAU RIAMARI
TIMOR-LESTE

Building Title:
MATERNITY BUILDING

Drawing Title:

Scale

Drawing By

Lucas Gomes B. Babo
Engineering-Archt

Date
1/2025

Checked By

Isaías Lino Borges
Engineering-Archt

Date
1/2025

Reviso By

Beldrich Soares
Chief DAPI MAS

Date
1/2025

Knowledge By

Indosq
Director NALP

Date
1/2025

Drawing No.


Indosq

Issue
2025


USE FIGURED DIMENSIONS IN PREFERENCE TO SCALE
ALL DIMENSIONS TO BE VERIFIED AND CHECKED ON SITE
ALL DIMENSIONS IN MILLIMETER

No.	ISSUE / AMENDMENT	DATE	INITIAL
1			
2			
3			
4			
5			
6			



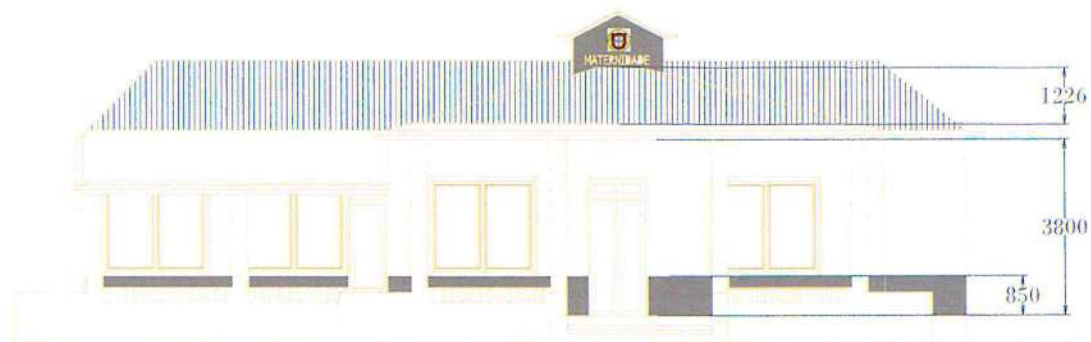

FRONTELEVATION
SCALE 1:100

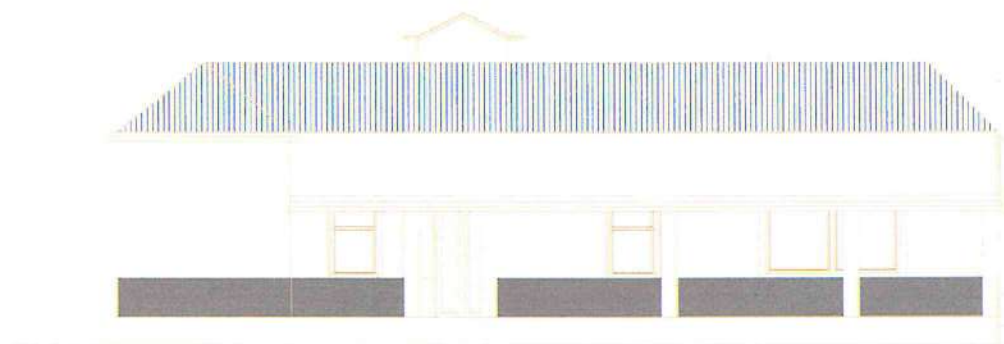

BACK ELEVATION
SCALE 1:100



Direção Nacional
Logística e património

Desing by :

Project:
REHABILITATION OF MATERNITY BUILDING

Site: BAUCAU RIAMARI
TIMOR-LESTE

Building Title:
MATERNITY BUILDING

Drawing Title:

Scale

Drawing By

Lucas Gomes Babo
Engineering/Mult

Date
...../2025

Checked By

Isaias Lino Borges
Engineering/Mult

Date
...../2025

Reviso By

Belchior Soares
Chief DAFT/MS

Date
...../2025

Knowledge By

Indos
Director NALP

Date
...../2025


Drawing No.

Issue
2025


NOTES

USE FIGURED DIMENSIONS IN PREFERENCE TO SCALE
ALL DIMENSIONS TO BE VERIFIED AND CHECKED ON SITE
ALL DIMENSIONS IN MILLIMETER.

No.	ISSUE / AMENDMENT	DATE	INITIAL
1			
2			
3			
4			
5			
6			

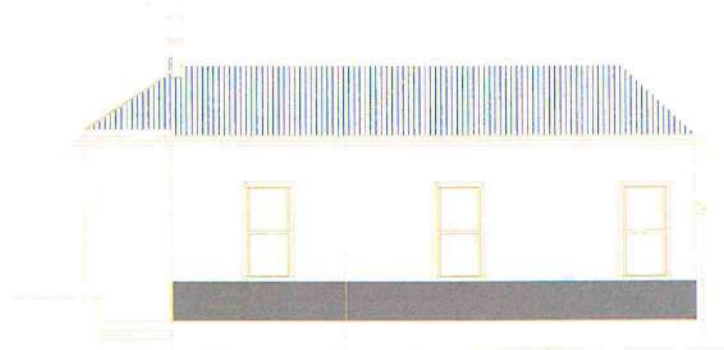

RIGHT ELEVATION
SCALE 1:100

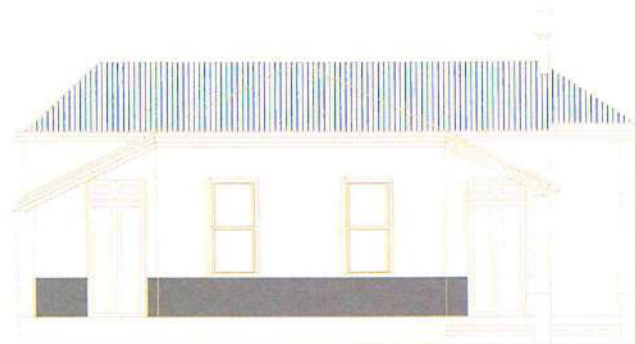

LEFT ELEVATION
SCALE 1:100

FLOOR PLAN
SCALE 1:100



MINISTÉRIO DA SAÚDE

Direção Nacional
Logística e património

Desing by :

Project:
REHABILITATION OF MATERNITY BUILDING

Site: BAUCAU RIAMARI
TIMOR-LESTE

Building Title:
MATERNITY BUILDING

Drawing Title:

Scale

Drawing By

Lucas Gomes B Bato
Engineering MSc

Date

2025

Checked By

Isaias Lino Borges
Engineering MSc

Date

2025

Reviso By

Belchior Soares
Chief DAPI MSc

Date

2025

Knowledge By

Dr. dos
Director NALP

Date

2025

Drawing No.

1
2
3
4
5
6


Issue

2025

USE FIGURED DIMENSIONS IN PREFERENCE TO SCALE
ALL DIMENSIONS TO BE VERIFIED AND CHECKED ON SITE
ALL DIMENSIONS IN MILLIMETER

ISSUE / AMENDMENT DATE INITIAL

NOTES

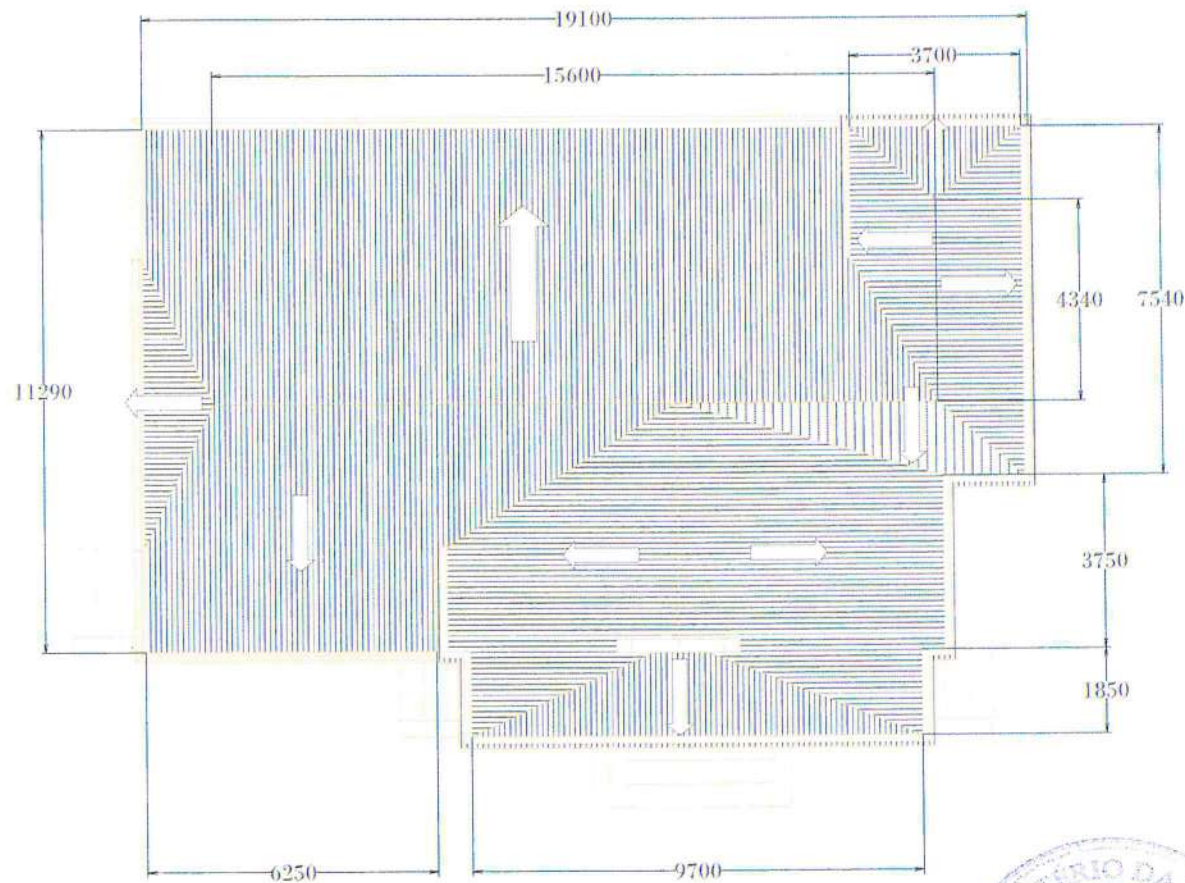

TOP PLAN
SCALE 1:100



PROJECT OWNER



Desing by :

Direcao Nacional
Logistic i patrimonio

MINISTÉRIO DA SAÚDE

PROJECT DETAILS

Project:
REHABILITATION OF MATERNITY BUILDING

Site:
BAUCAU RIAMARI
TIMOR-LESTE

Building Title:
MATERNITY BUILDING

Drawing Title:

Scale

Drawing By

Lucas Gomes Bôabo
Engineering/Arch

Date
...../2025

Checked By

Isaias Lino Borges
Engineering/Arch

Date
...../2025

Revis By

Belchier Soares
Civil Engineer

Date
...../2025

Knowledge By

Director NALP


Date
...../2025

Drawing No.

Issue
2025

USE FIGURED DIMENSIONS IN PREFERENCE TO SCALE
ALL DIMENSIONS TO BE VERIFIED AND CHECKED ON SITE
ALL DIMENSIONS IN MILLIMETER

No.	ISSUE / AMENDMENT	DATE	INITIAL
1			
2			
3			
4			
5			
6			

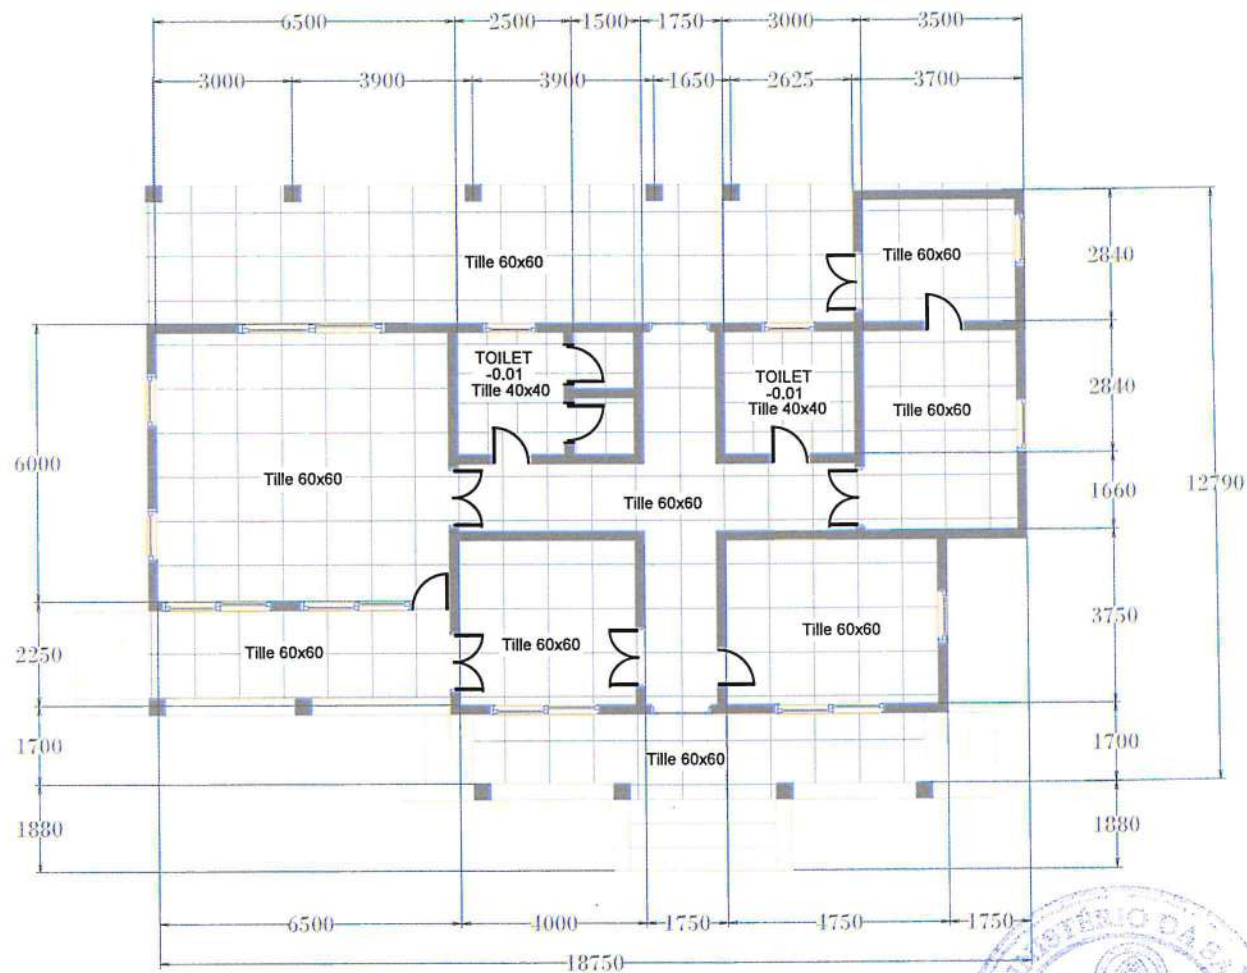

FLOOR PLAN
SCALE 1:100



Direcao Nacional
Logistic i patrimonio

Desing by :

Project:
REHABILITATION OF MATERNITY BUILDING

Site:
BAUCAU RIAMARI
TIMOR-LESTE

Building Title:
MATERNITY BUILDING

Drawing Title:

Scale

Drawing By

Lucas Gomes BBabo
Engineering-Mat

Date
1/2025

Checked By

Isaias Lino borges
Engineering-Mat

Date
1/2025

Reviso By

Belchior Soares
Quete DAPY MAS

Date
1/2025

Knowledge By

Director NALP


Date
1/2025

Drawing No.

Issue
2025

USE FIGURED DIMENSIONS IN PREFERENCE TO SCALE
ALL DIMENSIONS TO BE VERIFIED AND CHECKED ON SITE
ALL DIMENSIONS IN MILLIMETER

No.	ISSUE / AMENDMENT	DATE	INITIAL
1			
2			
3			
4			
5			
6			

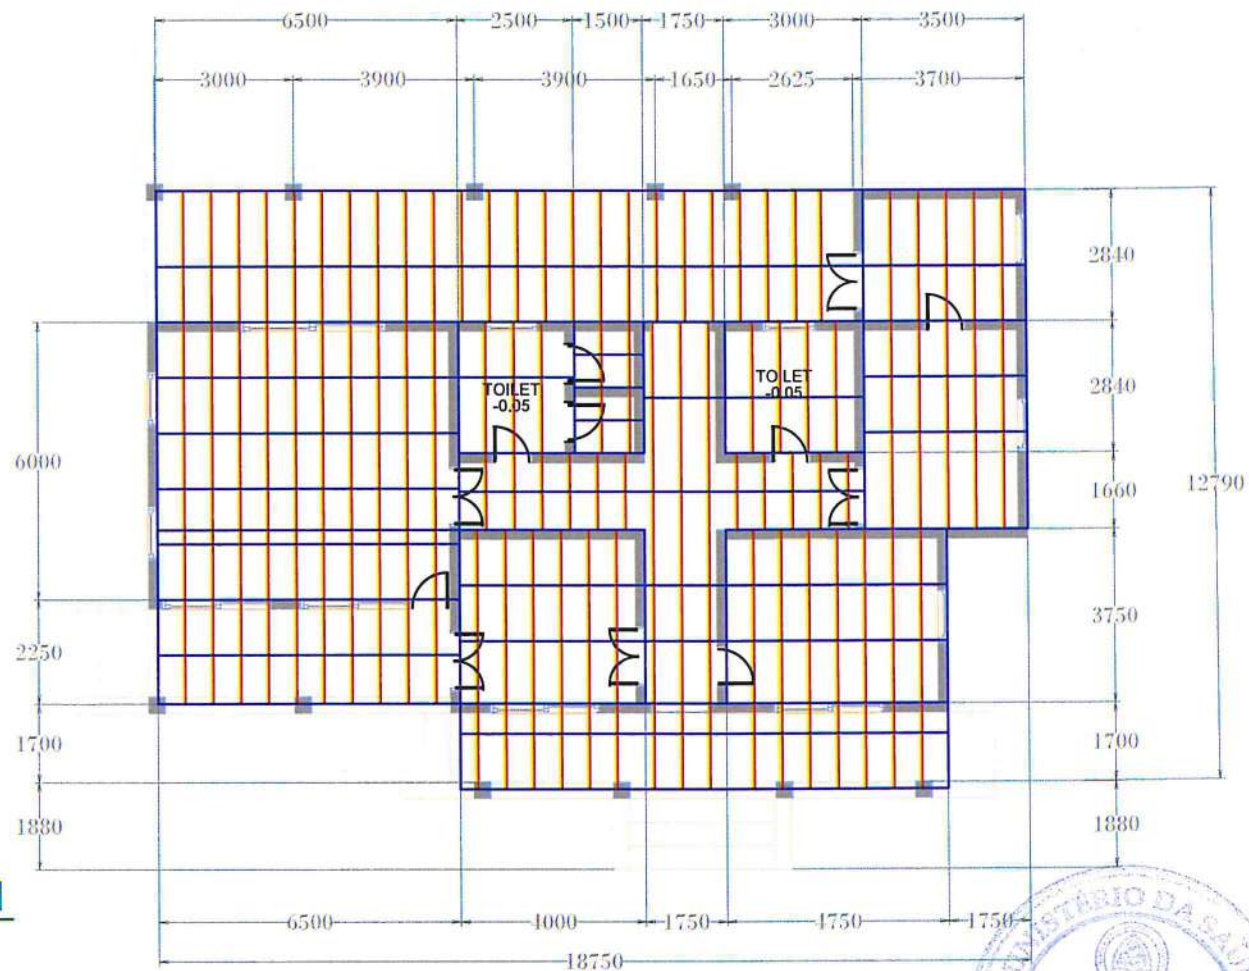

CHELING PLAN
SCALE 1:100



Desing by :

Direcao Nacional
Logostic i patrimonio

Project:
REHABILITATION OF MATERNITY BUILDING
Site: BAUCAU RUAMARI
TIMOR-LESTE
Building Title:
MATERNITY BUILDING

Drawing Title:

Scale

Drawing By

Lucas Gomes B88abo
Engineering-Mst

Date

...../2025

Checked By

Isaias Lino borges
Engineering-Mst

Date

...../2025

Revio By

Belchior Soares
Chefe DPTI IAS

Date

...../2025

Knowledge By

Director NALP

Date

...../2025

Drawing No.


Issue

Date

...../2025

USE FIGURED DIMENSIONS IN PREFERENCE TO SCALE
ALL DIMENSIONS TO BE VERIFIED AND CHECKED ON SITE
ALL DIMENSIONS IN MILLIMETER

No	ISSUE / AMENDMENT	DATE	INITIAL
1			
2			
3			
4			
5			
6			

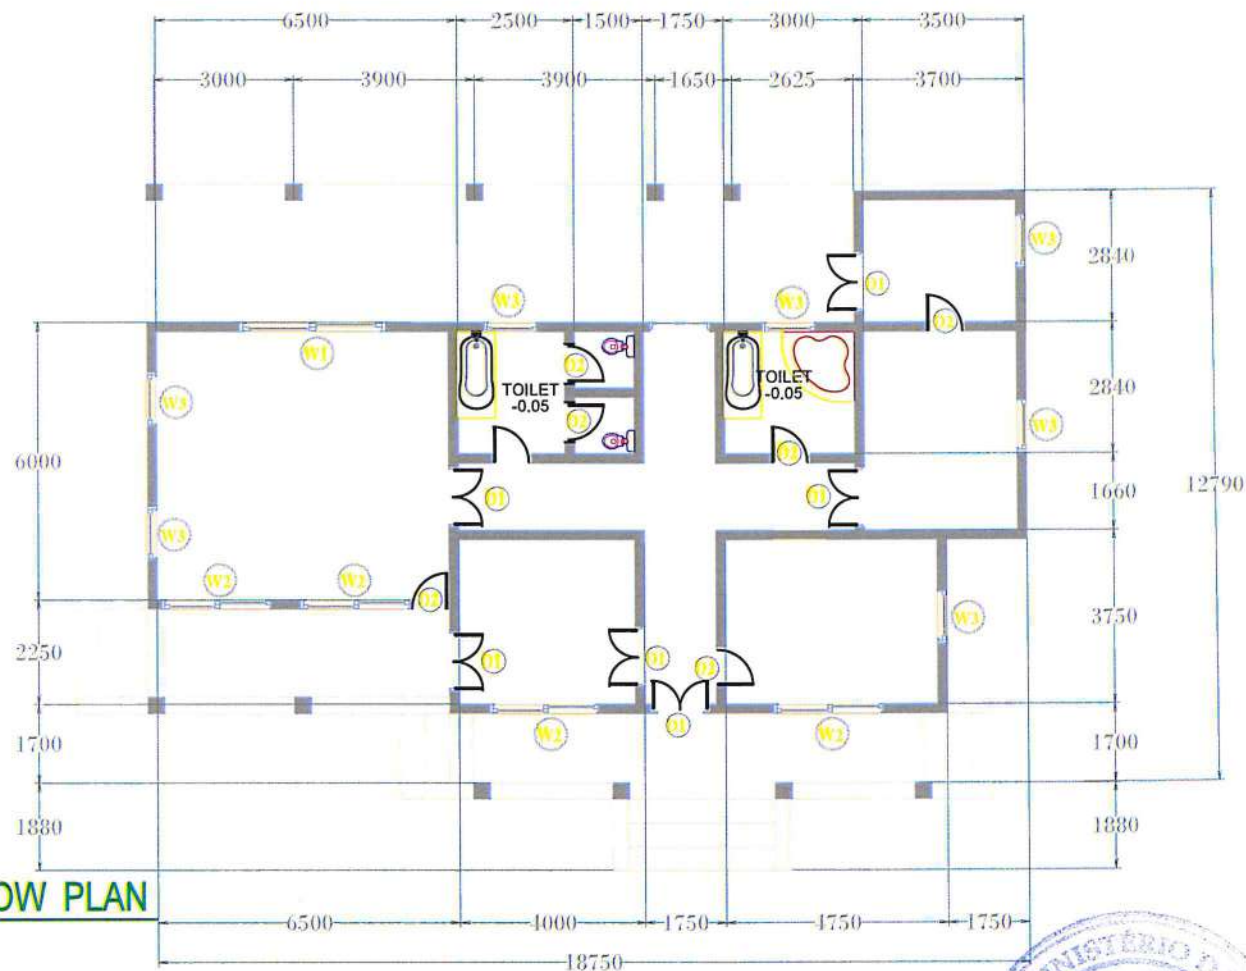

DOOR & WINDOW PLAN SCALE 1:100



Direcao Nacional
Logostic i patrimonio

Desing by :

Project:
REHABILITATION OF MATERNITY BUILDING

Site: BAUCAU RIAMARI
TIMOR-LESTE

Building Title:
MATERNITY BUILDING

Drawing Title:

Scale

Drawing By

Lucas Gomes B.B.Bo
Engineering/Mult

Date
/2025

Checked By

Isaias Lino borges
Engineering/Mult

Date
/2025

Revis By

Belchior Soares
Chefe DAPI M&S

Date
/2025

Knowledge By

Director NALP

Date
/2025


Drawing No.

Issue
2025

NOTES

USE FIGURED DIMENSIONS IN PREFERENCE TO SCALE.
ALL DIMENSIONS TO BE VERIFIED AND CHECKED ON SITE.
ALL DIMENSIONS IS MILLIMETER


No.	ISSUE / AMENDMENT	DATE	INITIAL
1			
2			
3			
4			
5			
6			

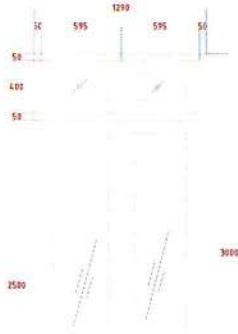

TYPE	D02
FRAME	ALUMINIUM FRAME
LEAF	ALUMINIUM
GLASS	5mm
LOUVER	-
HINGES	NOS. 35
FINISH	-
AMOUNT	NOS. 7
ACCESSORIES	DOOR STOPER NOS. 14
	DOOR CLOSER NOS. 14
	FLUSHBOLT NOS.14
	LOCKCASE NOS.14




D2 (07 Units)
SCALE 1:50

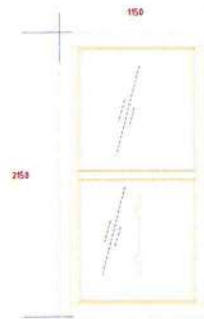

TYPE	W3
FRAME	ALUMINIUM FRAME
LEAF	ALUMINIUM
GLASS	5MM
SLIDING	ALUMINIUM
HINGES	NOS. -
FINISH	-
AMOUNT	NOS. 6
ACCESSORIES	DOOR STOPER NOS. 0
	DOOR CLOSER NOS. 0
	FLUSHBOLT NOS. 0
	LOCKCASE NOS. 0

W3 (06Units)
SCALE 1:50

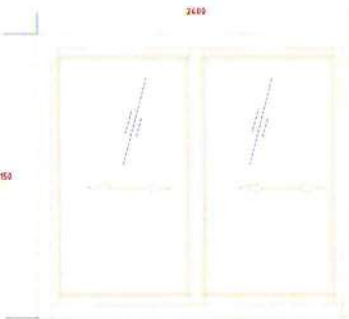

W2 (04 Units)
SCALE 1:50



W1 (01 Units)
SCALE 1:50

TYPE	W3
FRAME	ALUMINIUM FRAME
LEAF	ALUMINIUM
GLASS	5MM
SLIDING	ALUMINIUM
HINGES	NOS. -
FINISH	-
AMOUNT	NOS. 4
ACCESSORIES	DOOR STOPER NOS. 0
	DOOR CLOSER NOS. 0
	FLUSHBOLT NOS. 0
	LOCKCASE NOS. 0

TYPE	D01
FRAME	ALUMINIUM FRAME
LEAF	ALUMINIUM
GLASS	5mm
LOUVER	-
HINGES	NOS. 60
FINISH	-
AMOUNT	NOS. 6
ACCESSORIES	DOOR STOPER NOS. 12
	DOOR CLOSER NOS.12
	FLUSHBOLT NOS12
	LOCKCASE NOS.12

TYPE	W1
FRAME	ALUMINIUM FRAME
LEAF	ALUMINIUM
GLASS	5MM
SLIDING	ALUMINIUM
HINGES	NOS. -
FINISH	-
AMOUNT	NOS. 1
ACCESSORIES	DOOR STOPER NOS. 0
	DOOR CLOSER NOS. 0
	FLUSHBOLT NOS. 0
	LOCKCASE NOS. 0

DOOR, WINDOW & VENTILATION SCHEDULE
SCALE 1:50



Direcao Nacional
Logistic i patrimonio

Project:
REHABILITATION OF MATERNITY BUILDING
Site: BAUCAU RIAMARI
TIMOR-LESTE
Building Title:
MATERNITY BUILDING

Drawing Title:
Scale

Drawing By
Checked By
Date
Date

Reviso By
Date

Knowledge By
Drawing No.
Date
Issue

1	ISSUE / AMENDMENT	DATE	INITIAL
2			
3			
4			
5			
6			





Direcao Nacional
Logistic i patrimonio

MINIST

Desing by :

Project:
REHABILITATION OF MATERNITY BUILDING

Site: BAUCAU RIAMARI
TIMOR-LESTE

Building Title:
MATERNITY BUILDING

Drawing Title:

Scale

Drawing By

[Signature]
Lucas Gomes BSBao
Engineering-Mat

Date
...../...../2025

Checked By

[Signature]
Isaias Lino borges
Engineering-Mat

Date
...../...../2025

Revis By

[Signature]
Belchior Soares
Chief DAPY MS

Date
...../...../2025

Knowledge By

[Signature]
Director NALP
Date
...../...../2025

Drawing No.

Issue
2025

USE FIGURED DIMENSIONS IN PREFERENCE TO SCALE
ALL DIMENSIONS TO BE VERIFIED AND CHECKED ON SITE
ALL DIMENSIONS IN MILLIMETER

No.	ISSUE / AMENDMENT	DATE	INITIAL
1.			
2.			
3.			
4.			
5.			
6.			



PROJECT OWNER



MINISTÉRIO DA SAÚDE

Desing by :

Direcao Nacional
Logostic i patrimonio

Project:
REHABILITATION OF MATERNITY BUILDING

Site: BAUCAU RIAMARI
TIMOR-LESTE

Building Title:
MATERNITY BUILDING

Drawing Title:

Scale

Drawing By

[Signature]
Lucas Gomes B. B. B.
Engineering-Mat

Date
...../2025

Checked By

[Signature]
Isalao Lino borges
Engineering-Mat

Date
...../2025

Reviso By

[Signature]
Belchior Soares
Chief DAPI MAS

Date
...../2025

Knowledge By

[Signature]
Director NALP

Date
...../2025

Drawing No.

Issue
2025

NOTES

USE FIGURED DIMENSIONS IN PREFERENCE TO SCALE
ALL DIMENSIONS TO BE VERIFIED AND CHECKED ON SITE
ALL DIMENSIONS IN MILLIMETER

No.	ISSUE / AMENDMENT	DATE	INITIAL
1			
2			
3			
4			
5			
6			



Desing by :

Direcao Nacional
Logostic i patrimonio

Project:
REHABILITATION OF MATERNITY BUILDING

Site: BAUCAU RIAMARI
TIMOR-LESTE

Building Title:
MATERNITY BUILDING

Drawing Title:

Scale

Drawing By

Lucas Gomes B.B. Babo
Engineering-Mult

Date
...../2025

Checked By

Isaias Lino borges
Engineering-Mult

Date
...../2025

Reviso By

Berthier Soares
Chefe DAPV MAS

Date
...../2025

Knowledge By

Indose
Diretor NALP

Date
...../2025


Drawing No.

Issue
2025

USE FIGURED DIMENSIONS IN PREFERENCE TO SCALE
ALL DIMENSIONS TO BE VERIFIED AND CHECKED ON SITE
ALL DIMENSIONS IN MILLIMETER

No.	ISSUE / AMENDMENT	DATE	INITIAL
1			
2			
3			
4			
5			
6			

M&E
DRAWING

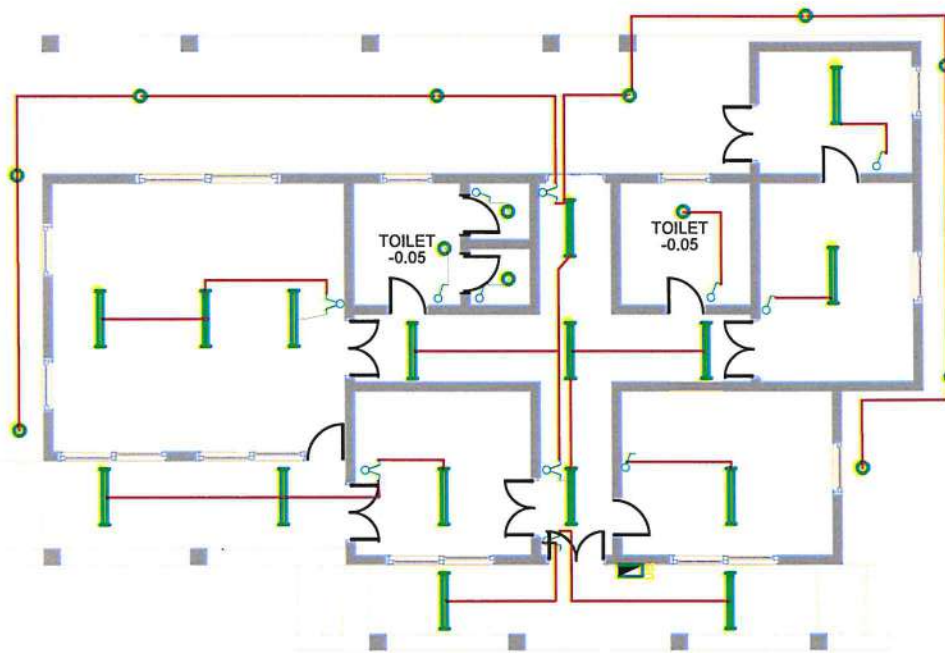

LEGEND :

SYMBOL	DESCRIPTION	UNITS
	DISTRIBUTION BOARD, 12 GROUP OF MCB + ACC COMPLETE TOP OF PANEL 1800mm AFFL	1
	PANEL METER 275000000000	-
	2x36W FLUORESCENT SURFACE MOUNTED LIGHT FITTING, C/W PRISMATIC DIFFUSER, ELECTRONIC BALLAST AND 15 FLUORESCENT LAMPS	19
	LIGHT PHILIPS BULB 24 WATT	13
	EXHAUST FAN 15 WATT	-
	DOUBLE SWITCHES 1500MM FFL	5
	SINGLE SWITCHES 1500MM FFL	7
	TWO WAY SWITCHES 1500MM FFL	2



Direcao Nacional
Logistic i patrimonio

MINIST

Project:
REHABILITATION OF MATERNITY BUILDING
Site: BAUCAU RIAMARI
TIMOR-LESTE
Building Title:
MATERNITY BUILDING

Drawing Title:
Scale

Drawing By
Checked By
Reviso By
Knowledge By
Drawing No.

Lucas Gomes BBabo
Engineering/Arch
Isaias Lino borges
Engineering/Arch
Belchior Soares
Chief DAPP Mds
Director NALP

Date
Date
Date
Date

...../2025
...../2025
...../2025
...../2025

Reviso By
Knowledge By
Drawing No.

Belchior Soares
Chief DAPP Mds
Director NALP


Date
Date
Date

...../2025
...../2025
...../2025

USE FIGURED DIMENSIONS IN PREFERENCE TO SCALE
ALL DIMENSIONS TO BE VERIFIED AND CHECKED ON SITE
ALL DIMENSIONS IN MILLIMETER

No.	ISSUE / AMENDMENT	DATE	INITIAL
1			
2			
3			
4			
5			
6			



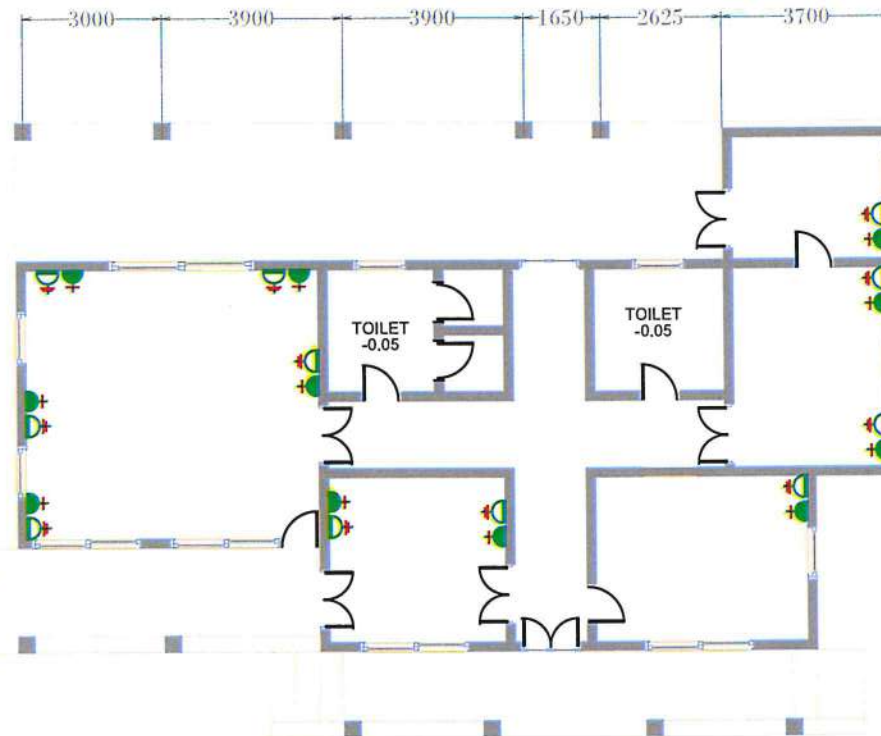

SINGLE LINE OUTLET PLAN
SCALE 1:100

LEGEND :

SYMBOL	DESCRIPTION	UNITS
	DISTRIBUTION BOARD, 800-1000mm TOP OF PANEL 1000mm APL	1
	POWER SWITCH 2700mmx400mm	-
	OUTLET 250WATT/16A FL + 500	11
	OUTLET 250WATT/16A FL + 1200	11

PROJECT OWNER



Desing by :

Direcao Nacional
Logostic i patrimonio

MINIST. DA SAUDE

PROJECT DETAILS

Project:
REHABILITATION OF MATERNITY BUILDING

Site:
BAUCAU RIAMARI
TIMOR-LESTE

Building Title:
MATERNITY BUILDING

Drawing Title:

Scale

Drawing By

Lucas Gomes Bbabo
Engineering/Arch

Date
/ /2025

Checked By

Isaias Line borges
Engineering/Arch

Date
/ /2025

Reviso By

Belchior Soares
Chief DAPI/MS

Date
/ /2025

Knowledge By

Director NALP

Date
/ /2025


Drawing No.

Belchior Soares

Date
/ /2025

USE REQUIRED DIMENSIONS IN PREFERENCE TO SCALE
ALL DIMENSIONS TO BE VERIFIED AND CHECKED ON SITE
ALL DIMENSIONS IN MILLIMETER

No.	ISSUE / AMENDMENT	DATE	INITIAL
1			
2			
3			
4			
5			
6			

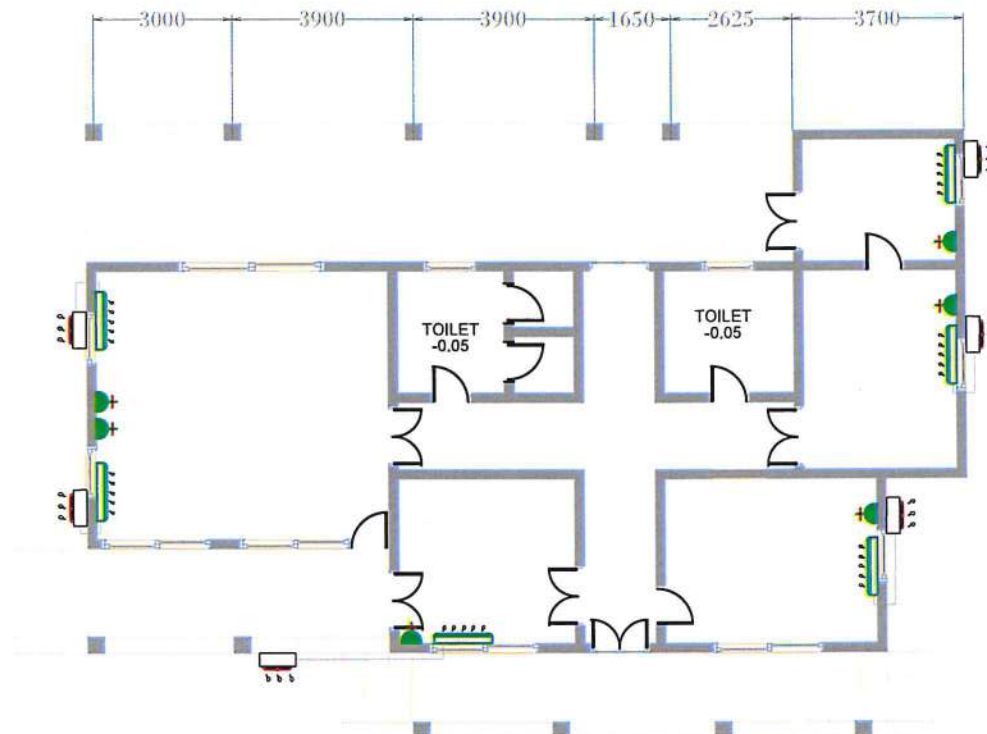

INSTALLATION AIR CONDITIONING (AC) PLAN
SCALE: 1/100

LEGEND :

SYMBOL	DESCRIPTION	UNITS
	DISTRIBUTION BOARD, 400V/10kV/250V and TOP OF PANEL, 100mm APPL.	1
	POWER INVERTER 2725000000000000	-
	Single Line Outlet	6
	Air Condition Panasonic 1 PK	4
	Air Condition Panasonic 1,5PK	2
	Outdoor	6



MINIST. DA SAUDE

Direcao Nacional
Logistic i patrimonio

Desing by :

Project:
REHABILITATION OF MATERNITY BUILDING

Site:
BAUCAU RIAMARI
TIMOR-LESTE

Building Title:
MATERNITY BUILDING

Drawing Title:

Scale

Drawing By

Lucas Gomes B. Babo
Engineering Multi

Date
/ / 2025

Checked By

Isaias Lino Borges
Engineering Multi

Date
/ / 2025

Reviso By

Belchior Soares
Chefe DAPI M&S

Date
/ / 2025

Knowledge By

Director NALP

Date
/ / 2025


Drawing No.

1


Issue
2025

USE FIGURED DIMENSIONS IN PREFERENCE TO SCALE.
ALL DIMENSIONS TO BE VERIFIED AND CHECKED ON SITE.
ALL DIMENSIONS IN MILLIMETER.

No.	ISSUE / AMENDMENT	DATE	INITIAL
1			
2			
3			
4			
5			
6			

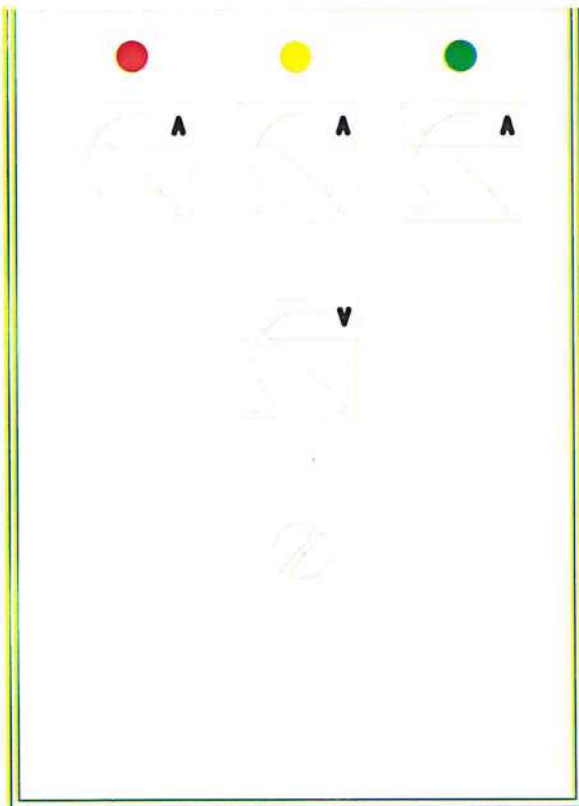

FRONT-VIEW

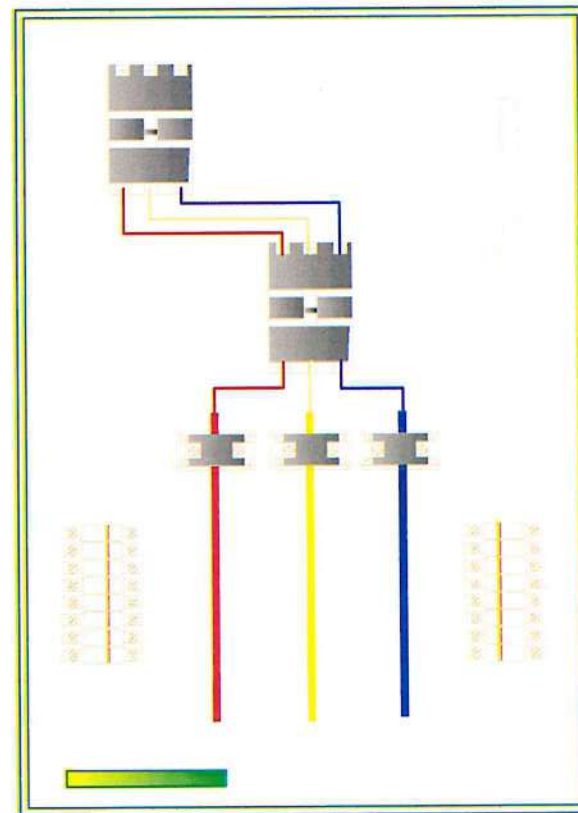

INTERIOR-VIEW

DETAIL PANEL SPD-A PLAN
SCALE: 1:100



Direção Nacional
Logística e património

Desing by :

Project:
REHABILITATION OF MATERNITY BUILDING

Site: BAUCAU RIAMARI
TIMOR-LESTE

Building Title:
MATERNITY BUILDING

Drawing Title:

DETAIL PANEL BOX PLAN

Scale

1:100

Drawing By

Lucas Gomes Brabo
Engineering-Archit

Date

../2025

Checked By

Isaias Lino Borges
Engineering-Mult

Date

../2025

Revis By

Belchior Soares
Chief DAPI M&S

Date

../2025

Knowledge By

Director NALPS

Date

../2025

Drawing No.







Issue

2025

6

USE FOURED DIMENSIONS IN PREFERENCE TO SCALE
ALL DIMENSIONS TO BE VERIFIED AND CHECKED ON SITE
ALL DIMENSIONS IS MILLIMETER

No.	ISSUE / AMENDMENT	DATE	INITIAL
1			
2			
3			
4			
5			
6			

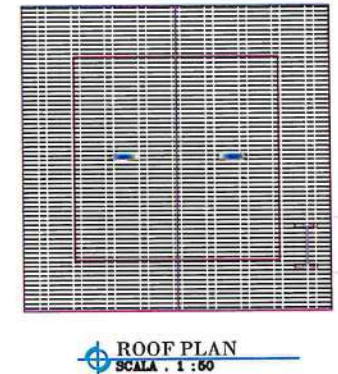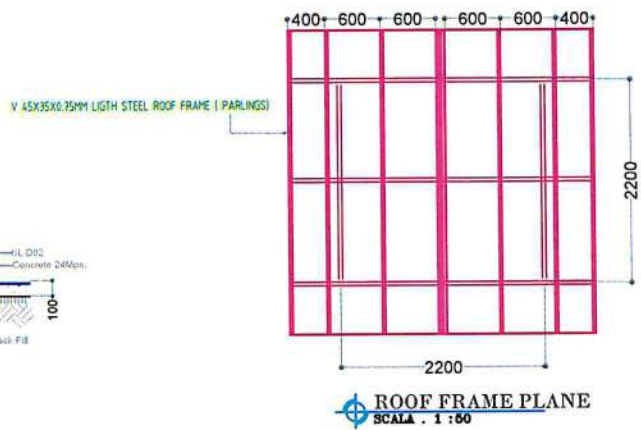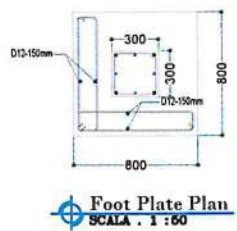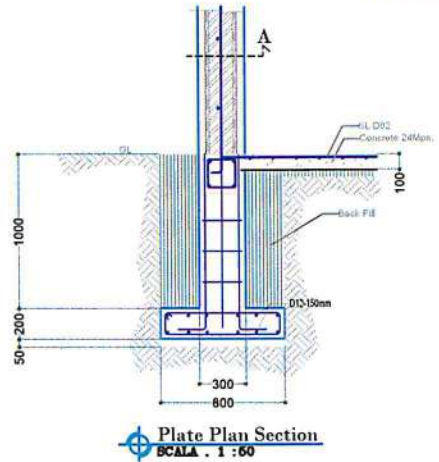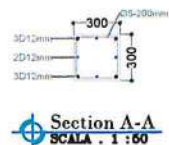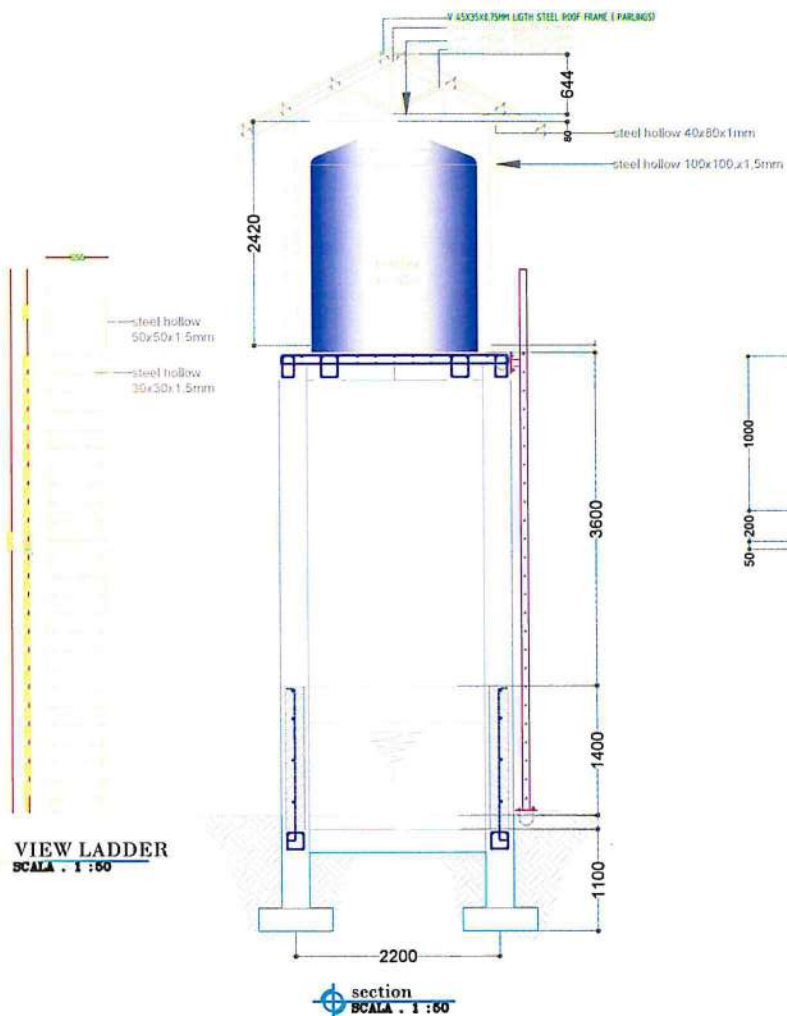

MINIST

Direcao Nacional
Logistic i patrimonio

Project:
REHABILITATION OF MATERNITY BUILDING
Site: BAUCAU RIAMARI
TIMOR-LESTE
Building Title:
MATERNITY BUILDING

Drawing Title:
Scale

Drawing By
Checked By
Revis By
Date
Date
Date


Knowledge By
Drawing No:
Date
Issue



No.	ISSUE / AMENDMENT	DATE	INITIAL
1			
2			
3			
4			
5			
6			

LEGEND :

- ① IN & EXIT
- ② MATERNITY BUILDING
- ③ NEW CONSTRUCTION LOUNDRY
- ④ NEW CONSTRUCTION WATER TOWER
- ⑤ RESIDENT COMMUNITY
- ⑥ AMBULANCE PARKING

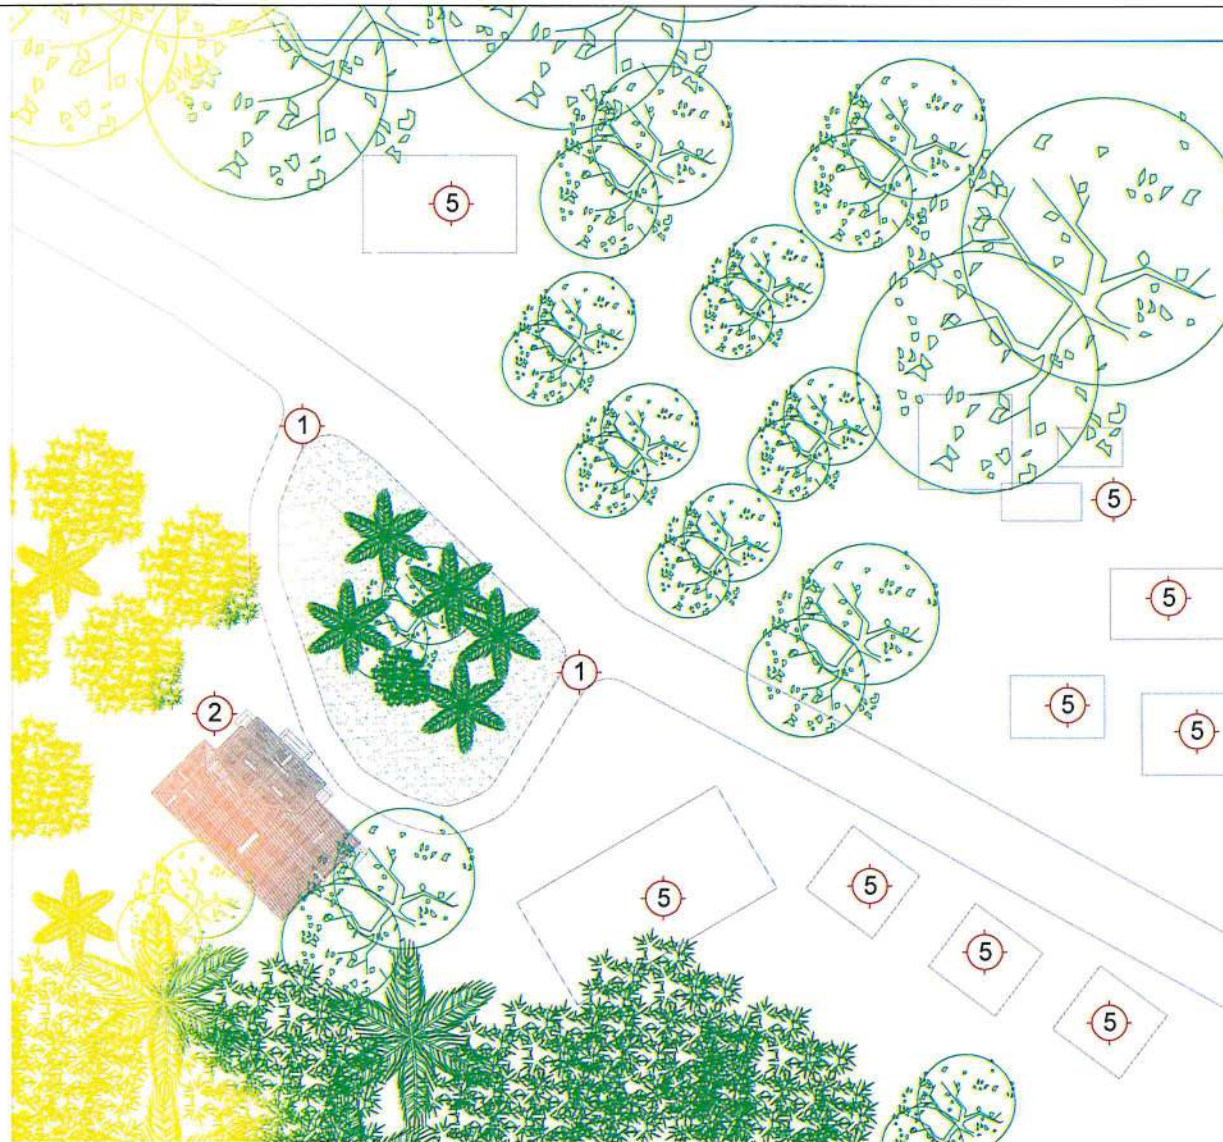

PROJECT OWNER



Desing by :

Direcao Nacional
Logistic i patrimonio

Project:
REHABILITATION OF MATERNITY BUILDING

Site: Riamara, Baucau
Timor-Leste

Building Title:
MATERNITY BUILDING

Drawing Title:

Site Existing

Scale

1:500

Drawing By

Lucas Gomes Sabo
Engineering-Mat

Date

...../2025

Checked By

Isaías Lino Borges
Eng. Coordinate-Mat

Date

...../2025

Review By

Belchior Soares
Chief DNAP/Mat

Date

...../2025

Knowledge By

Julio dos Santos, Ent
Chief DNAP

Date

...../2025

Drawing No

.....

Issue

.....


Date

...../2025

NOTES


ALL DIMENSIONS IN PREFERENCE TO SCALE
ALL DIMENSIONS TO BE VERIFIED AND CHECKED ON SITE

No	ISSUE / AMENDMENT	DATE	INITIAL
1			
2			
3			
4			
5			
6			

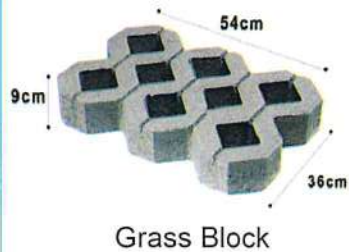


Notes:


1. All retaining wall must be cleaned and repaired to original.
2. All important components near the building must be installed and repaired accordingly

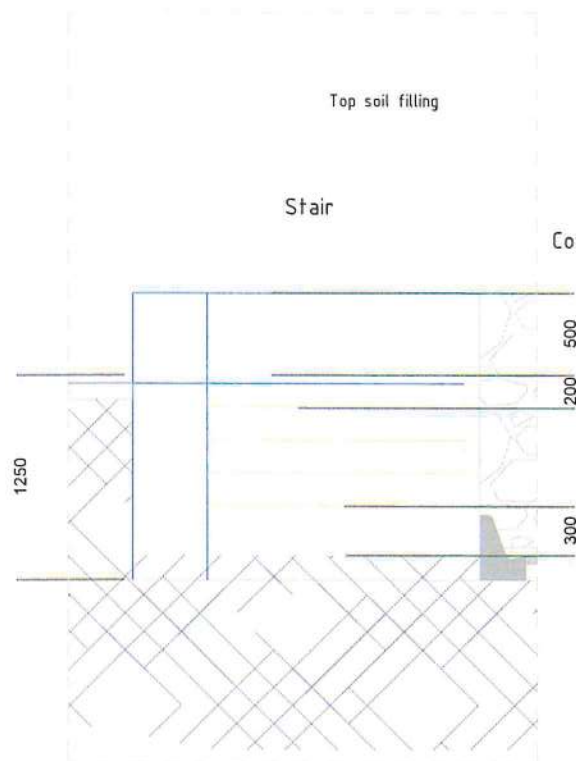

A Detail Stair
01 SCALE 1:50

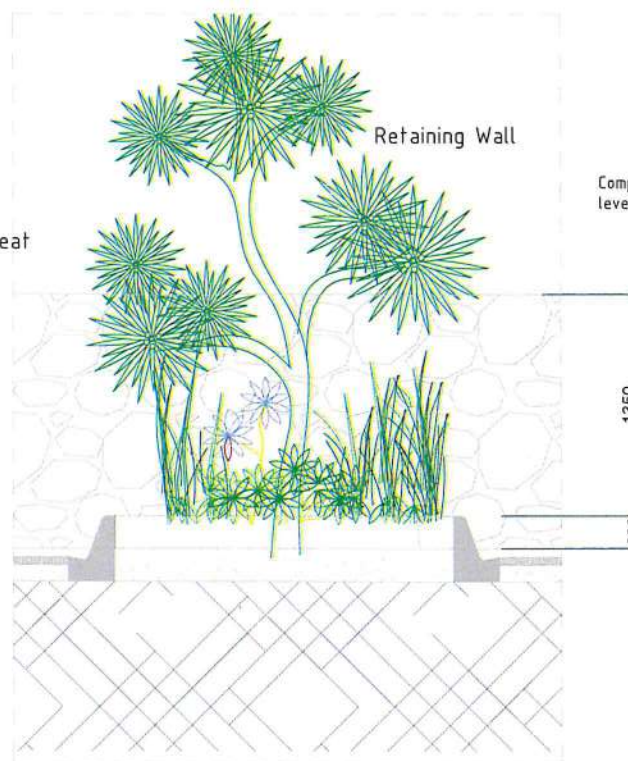

B Detail Garden and Grass Block
01 SCALE 1:20

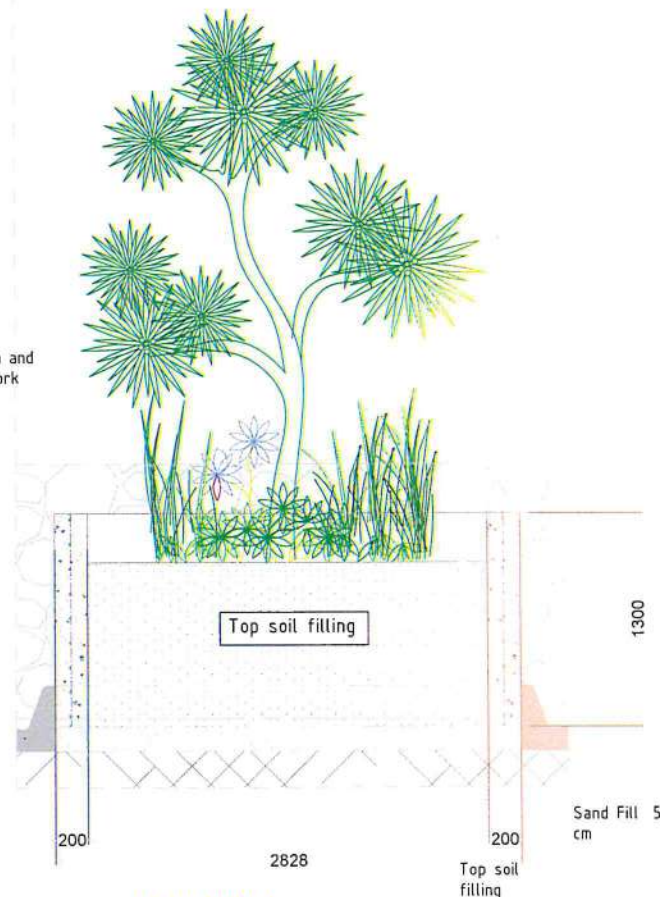


C Detail Blok
01 SCALE 1:20

PROJECT OWNER			PROJECT DETAILS						NOTES:				
  MINISTÉRIO DA SAÚDE	Desing by :	Direcao Nacional Logostic i patrimonio	Project: REHABILITATION OF MATERNITY BUILDING	Drawing Title:	Drawing By	Checked By	Review By	Knowledge By	Drawing No	USE FIGURED DIMENSIONS IN PREFERENCE TO SCALE ALL DIMENSIONS TO BE VERIFIED AND CHECKED ON SITE ALL DIMENSIONS IS MILLIMETER			
			Site: Riamare, Baucau Timor-Leste	Detail	 Lucas Gomes Babo Engineering MSc	 Isaias Lino Borges Eng. Coordenador MSc	 Belchior Soares Chefe DAA / Mds	 Julio dos Santos, Ent Diretor DNALP		No.	ISSUE / AMENDMENT	DATE	INITIAL
			Building Title: MATERNITY BUILDING	Scale 1:50	Date/...../2025	Date/...../2025	Date/...../2025	Date/...../2025	Issue 2025	1			
										2			
									ISSUE / AMENDMENT DATE INITIAL				

SPESIFIKASI PRODUK KANSTEEN

No	Tipe Kansteen	Dimensi						
		A	B	C	D	F	Volume	Berat
		mm					m ³	kg
1	Kansteen Jumbo (60x30X25/22)	220	300	250	600	70	0.042	97.674
2	Kansteen Jumbo (60x30X25/22) Sal. Air	220	300	250	600	70	0.038	87.285
3	Kansteen (60x25X22/18)	180	250	220	600	70	0.029	67.010
4	Car Stopper (60x15x15/10)	100	600	150	600	100	0.013	29.325
5	Kansteen B2 (40x28x15/12)	120	280	150	400	70	0.015	35.615
6	Kansteen B4 (40x25x12/9)	90	250	120	400	100	0.011	25.756
No	Tipe Kansteen	Dimensi						
		A2	B2	C2	D	F2	Volume	Berat
		mm					m ³	kg
1	Kansteen Sofa (30x30x60)	61	300	300	600	100	0.035	79.488

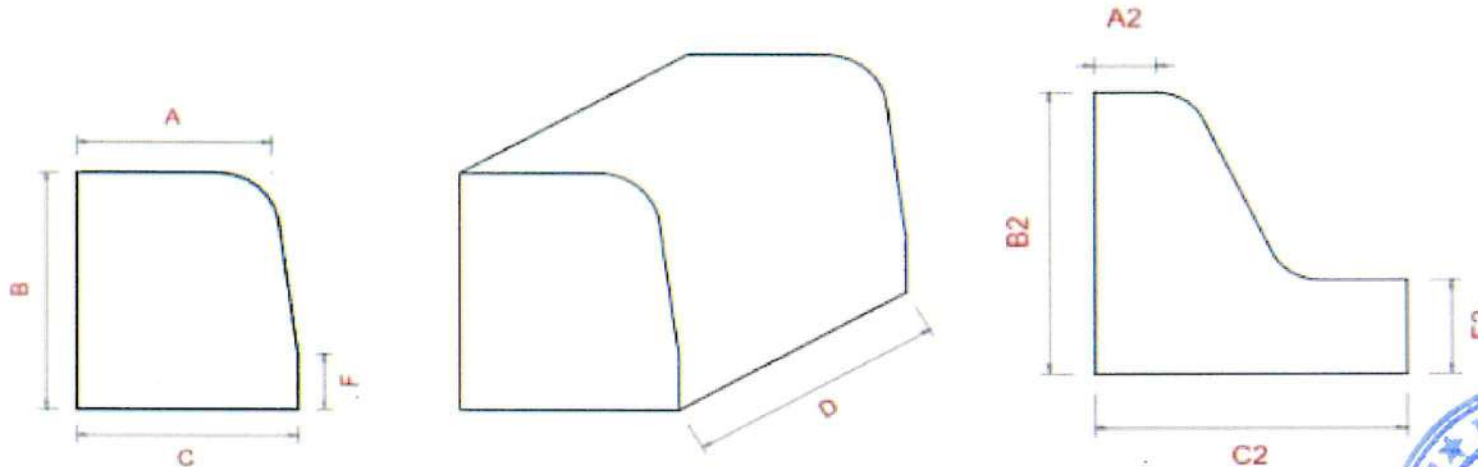

Notes:

1. the installation of the canopy will be in accordance with the drawings.
2. sizes will be determined by the Engineer in tables No. 1 and 2.



Desain by :

Direcao Nacional
Logostic i patrimonio

Project:
REHABILITATION OF MATERNITY BUILDING

Site:	Riamare, Baucau Timor-Leste
-------	--------------------------------

Building Title: MATERNITY BUILDING

Drawing Title:

Matrix

Scale

N/A

Drawing By

Lucas Gomes Babo

Date 1/2025

PROJECT DETAILS

Checked By

Isaias Lino borges

Date _____
_____/_____/2025

Review By


Belchior Soares
Chaveiro, 11/11/2018

Date
...../...../2025

Knowledge By

Prof. Dr.
Julio dos Santos, En.
Presidente IREAP

Date: 1/2025

Drawing No.

USE FIGURED DIMENSIONS IN PREFERENCE TO SCALE
ALL DIMENSIONS TO BE VERIFIED AND CHECKED ON SITE
ALL DIMENSIONS IS MILLIMETER

No.	ISSUE / AMENDMENT	DATE	INITIAL
1			
2			
3			
4			
5			
6			



PROJECT OWNER



REPÚBLICA DEMOCRÁTICA DE TIMOR-LESTE
IX GOVERNO CONSTITUCIONAL



MINISTÉRIO DA SAÚDE

Desing by :

Direcao Nacional
Logostic i patrimonio

PROJECT DETAILS

Project:
REHABILITATION OF MATERNITY BUILDING

Drawing Title:

Drawing By

Checked By

Review By

Knowledge By

Drawing No.

Site: Riamare, Baucau
Timor-Leste

Respective View

Scale

Lucas Gomes Babo
Engineering-Mark

Isaias Lino borges
Eng. Coordenador-MGH

Beichlor Soares
Chief DAPI-Mas

Julio dos Santos, Enl
Director DNALP

Building Title:
MATERNITY BUILDING

N/A

Date
...../...../2025

Date
...../...../2025

Date
...../...../2025

Date
...../...../2025

Issue
...../...../2025

NOTES:

USE FIGURED DIMENSIONS IN PREFERENCE TO SCALE.
ALL DIMENSIONS TO BE VERIFIED AND CHECKED ON SITE.
ALL DIMENSIONS IS MILLIMETER

No	ISSUE / AMENDMENT	DATE	INITIAL
1			
2			
3			
4			
5			
6			